 


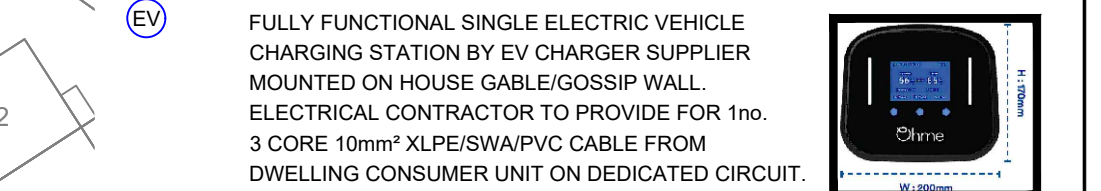
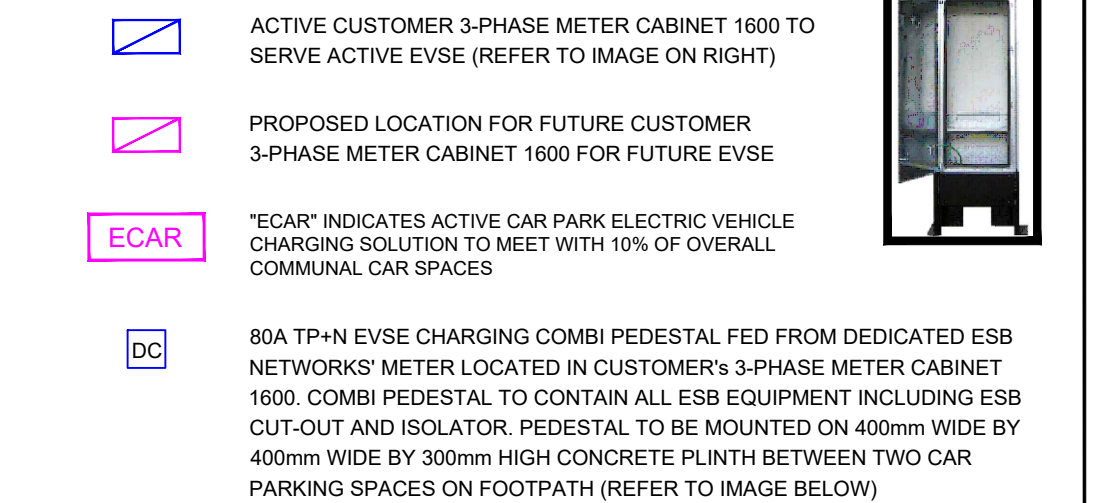


125mm DIAMETER ESB uPVC RED DUCTING DEDICATED FOR LOCAL LV CABLES WITH WARNING TAPE OVER DUCT. MAIN CONTRACTOR TO INSTALL 90mm DIAMETER HOCKEY STICKS INTO AND OUT OF CONCRETE PLINTH FOR ROUTING OF ESB CABLES

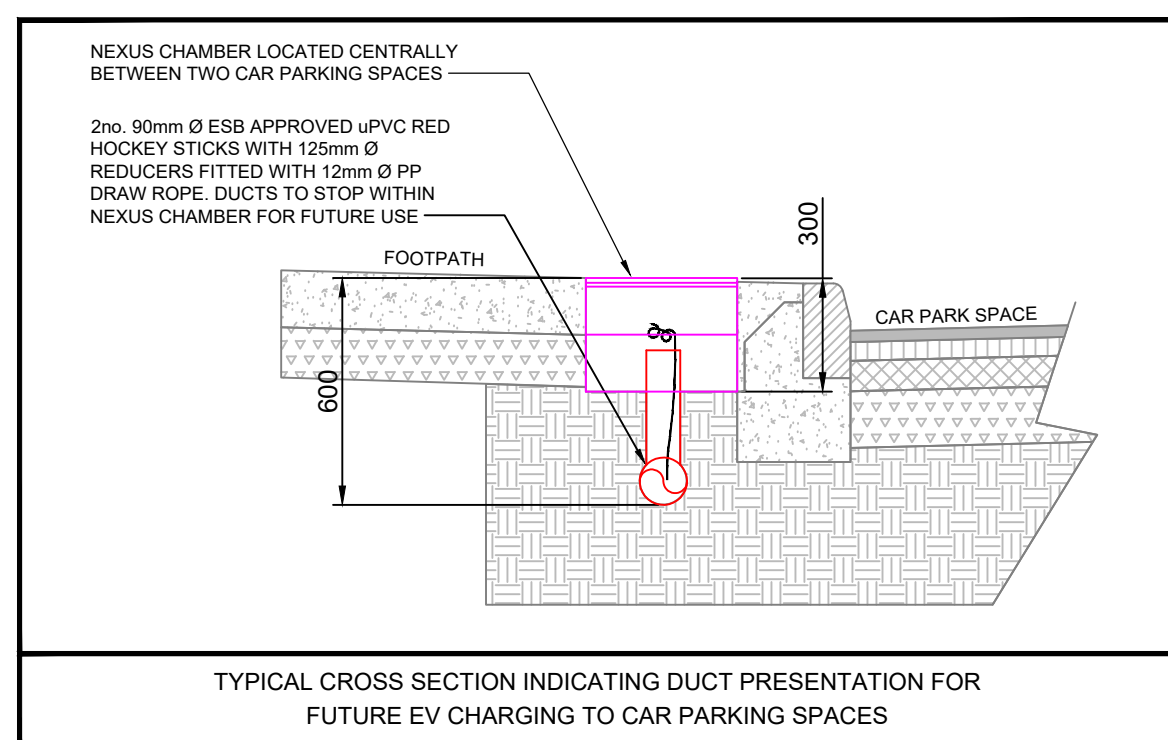

BLUE HATCHING DENOTES COMMUNAL CAR PARKING SPACE TO BE SERVED BY PUBLIC ELECTRIC VEHICLE RECHARGING EQUIPMENT OR PROVIDED WITH DUCTING FOR FUTURE EV RECHARGING EQUIPMENT AT A LATER DATE

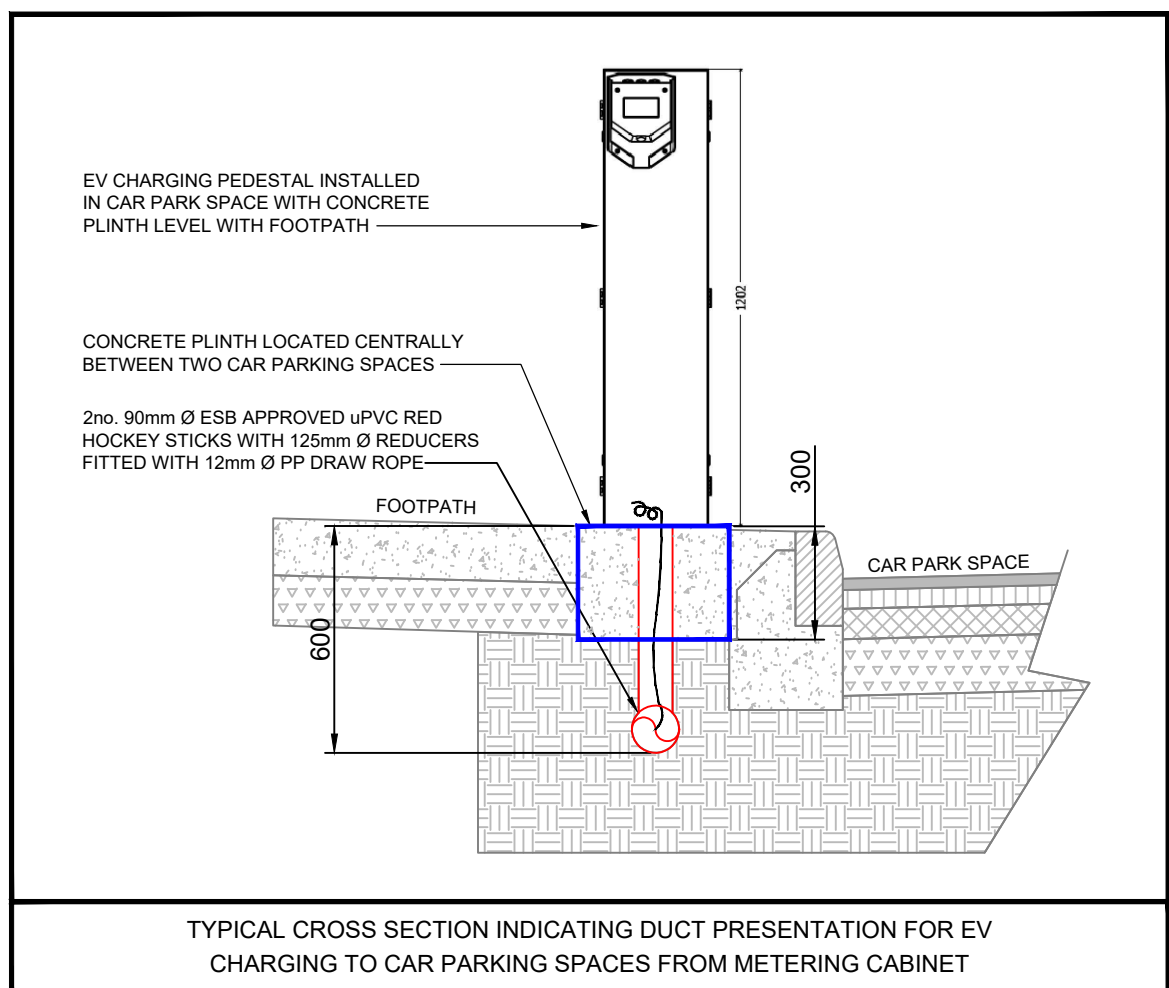

TOTAL HOUSES 127no.

TOTAL CAR PARKING SPACES 287no.

OFF-CURTILAGE PARKING SPACES 33no. IN TOTAL (INCLUDING 15no. AT CRECHE)

ON-CURTILAGE PARKING SPACES 254no. IN TOTAL

4no. OFF-CURTILAGE CAR PARKING SPACES FITTED WITH ACTIVE CHARGING:

- HOUSE TYPE C1 - No. 14 (2no. SPACES)
- CRECHE (2no. INCLUDING ACCESSIBLE SPACE)

29no. OFF-CURTILAGE CAR PARKING SPACES DUCTING FOR FUTURE CHARGING:

- HOUSE TYPE C1 - No. 14 (2no. SPACES)
- HOUSE TYPE E - No's 05, 06, 17 & 18 (8no. SPACES)
- HOUSE TYPE E1 - No's 08 & 19 (4no. SPACES)
- HOUSE TYPE D1 - No. 129 (2no. SPACES)
- CRECHE (13no. SPACES)

11 HOUSES (22no. SPACES) ON-CURTILAGE CAR PARKING SPACES FITTED WITH ACTIVE HOME CHARGER:

- HOUSE TYPE D - No's 15, 105, 111, 116 & 118 (10no. SPACES)
- HOUSE TYPE C - No's 108 & 117 (4no. SPACES)
- HOUSE TYPE C1 - No's 107 & 109, (4no. SPACES)
- HOUSE TYPE C3 - No's 106 & 110 (4no. SPACES)

107 HOUSES (214no. SPACES) ON-CURTILAGE CAR PARKING SPACES FITTED WITH CABLE FOR FUTURE CHARGING

PL2	UPDATED FOR FURTHER INFORMATION	KP	KP	DC	19/08/2025
PL1	PLANNING ISSUE	KP	KP	DC	02/04/2025
B	DESIGN ISSUE	KP	KP	DC	11/03/2025
A	DESIGN ISSUE	KP	KP	DC	19/11/2024
ISSUE	DESCRIPTION	DRN	ORIG	APP	DATE

**MANDE**  
CONSULTING ENGINEERS

Unit 4 Oak Close  
Western Business Park  
Dublin 12. D12 R8C6

T: (01) 4508485  
W: [www.mande.ie](http://www.mande.ie)  
E: [info@mande.ie](mailto:info@mande.ie)

TITLE	ELECTRIC VEHICLE SUPPLY EQUIPMENT (EVSE) DUCTING LAYOUT SITE PLAN
-------	---

PROJECT No. 24022		DATE: NOVEMBER 2024	
A1	SCALE 1:500	DRG No.	24022-MAE-00-XX-DR-E-6001

THIS DRAWING IS COPYRIGHT© ALL RIGHTS RESERVED. NO PART OF THIS DRAWING MAY BE REPRODUCED, STORED IN A RETRIEVAL SYSTEM OR TRANSMITTED IN ANY FORM OR BY ANY MEANS WITHOUT THE PRIOR WRITTEN PERMISSION FROM MARINE CORPS ENGINEERS LTD.